




QUICK-ASSOCIATES, P.A.
architects/planners

774 N. W. 10th St., Suite 1403
Fort Lauderdale, FL 33304
Tel: (954) 571-2200
Fax: (954) 571-1200

		<p>OAK MANOR MARKET SHOPPING CENTER Mebane, North Carolina Barnett Properties, LLC</p>	<p>Drawn: JDC 23 June 2009 11:45 AM ALL RIGHTS RESERVED</p>	<p>Not shown and not shown on this plan are the existing structures, utility lines, and other features not shown on this plan. The information shown on this plan is based on information provided by the client and is not warranted. The architect and its representatives will not be responsible for any errors or omissions on this plan. © 2009 QUICK ASSOCIATES, P.A.</p>	<p>Project: 195008.00 Drawn by: JDC Checked by: DDC Date: 23 June 2009 Title: LEASING PLAN</p>	<p>NOT FOR CONSTRUCTION Sheet: LP-1 of 1</p>
--	--	---	---	--	--	--

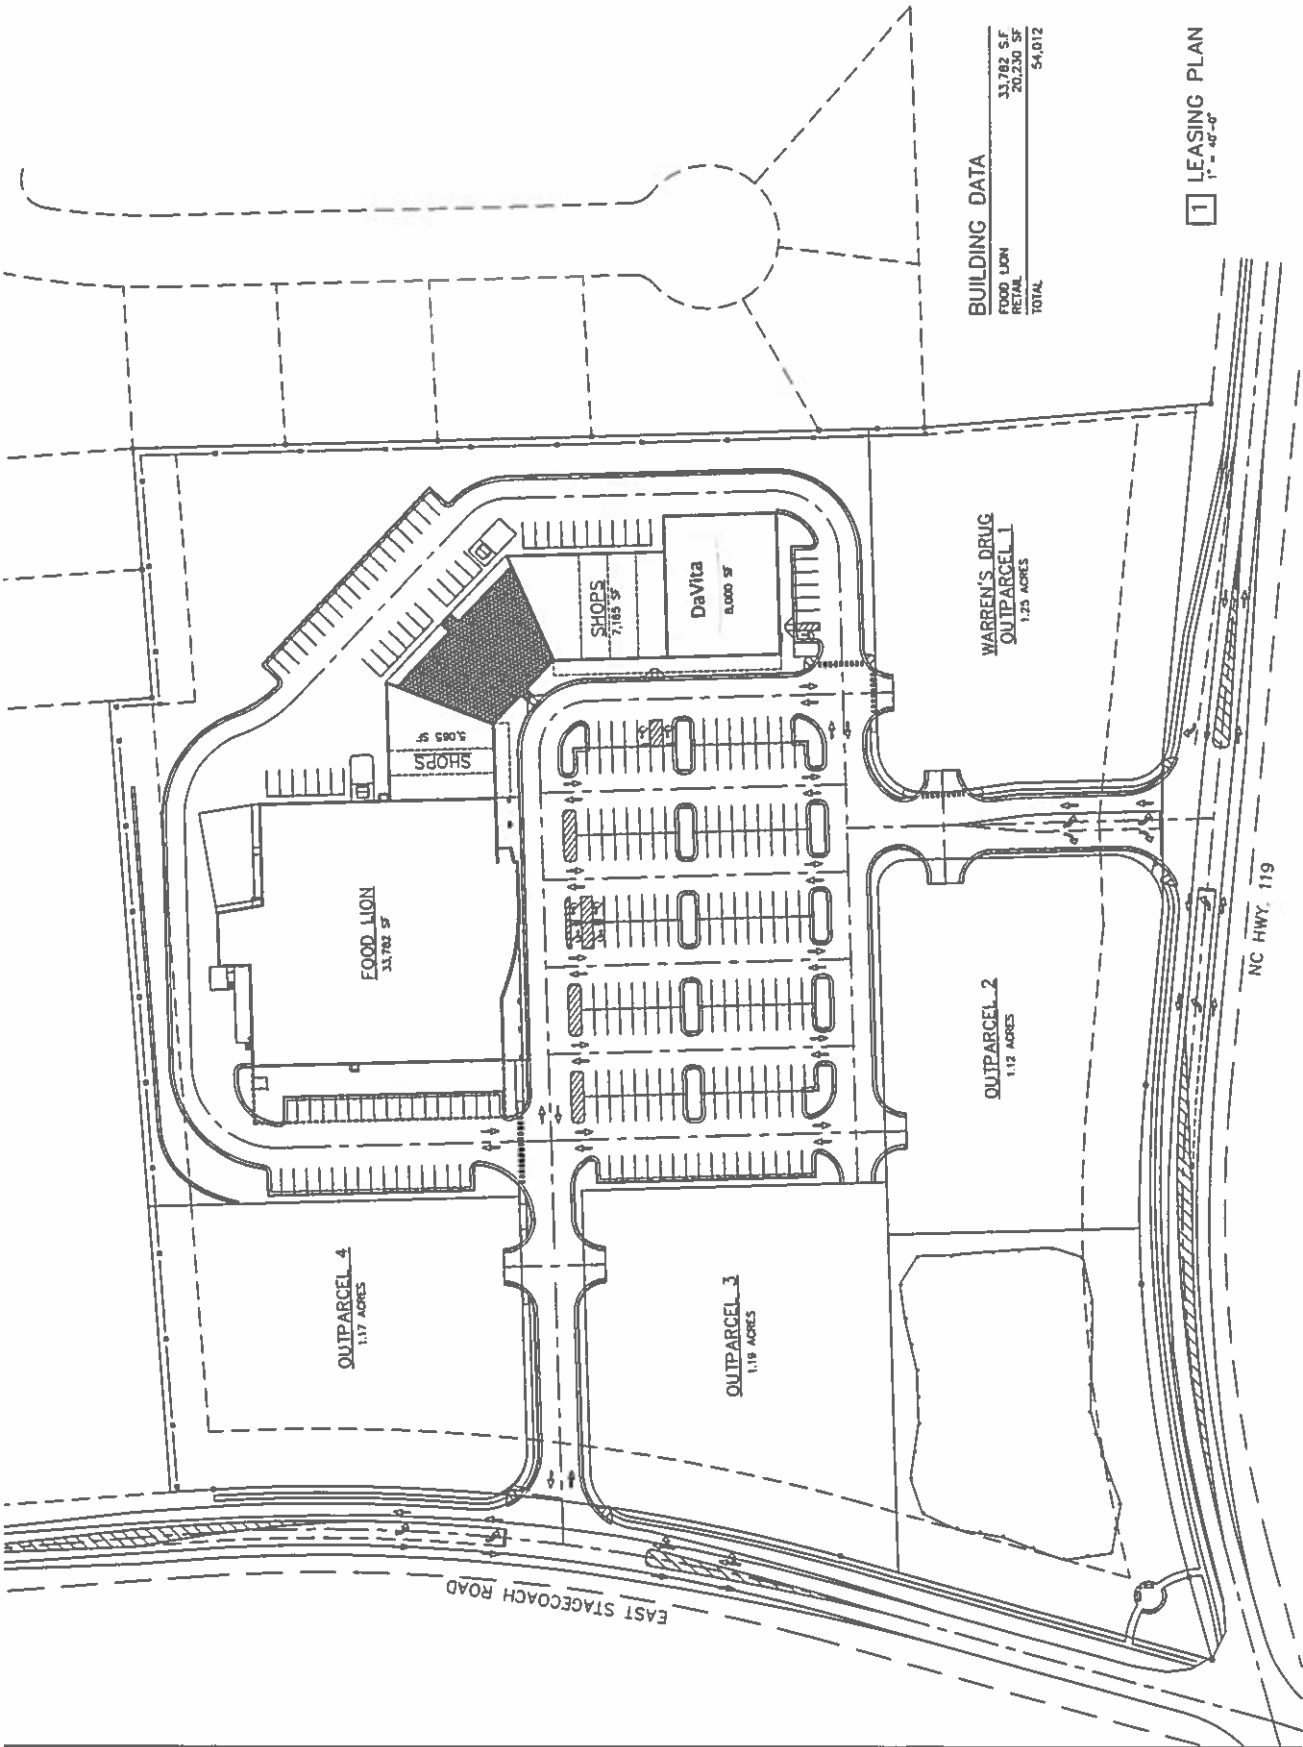

BUILDING DATA

FOOD LION	33,782 SF
RETAIL	20,230 SF
TOTAL	54,012

1 LEASING PLAN
1" = 40'-0"